



PLAN VIEW
SCALE: 1"=1'-0"

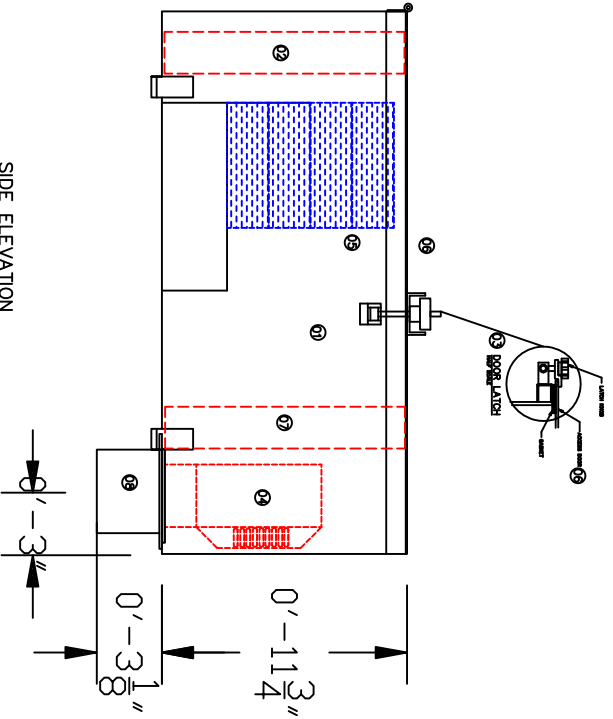

SIDE ELEVATION
SCALE: 1"=1'-0"

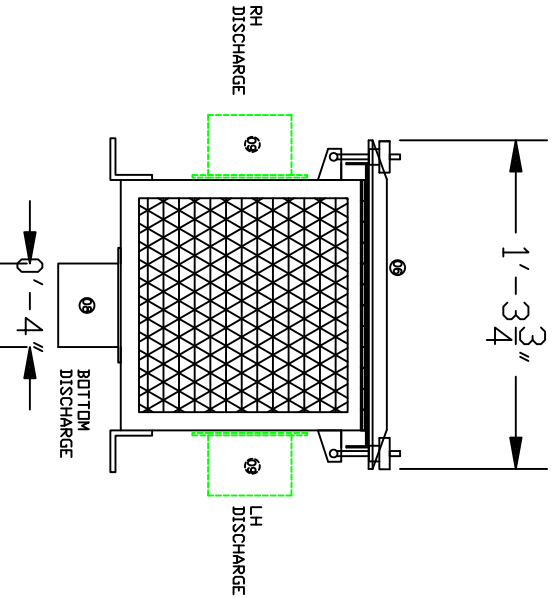

FRONT ELEVATION
SCALE: 1"=1'-0"

2'-2"

1'-4 7/8"

1'-3 1/4"

MOUNTING HOLES
SCALE: 1"=1'-0"

MATERIAL LIST

ITEM NO.	QTY	DESCRIPTION
1	1	TANK, ALUM, 16 GA
2	2	2" PREFILTER, 30% ASHRAE EFFICIENCY
3	2	LATCH KNOBS
4	1	FAN, 115VAC, 140W
5	2	HONEYCOMB MATRIX
6	1	FILTER ACCESS DOOR, WITH GASKET AND LATCHES
7	1	2" POSTFILTER, 30% ASHRAE EFFICIENCY
8	1	4" OD DISCHARGE
9	1	4" OD OPTIONAL SIDE DISCHARGE

- NOTES:
- DESIGN AIR FLOW: 900CFM
 - UNIT WEIGHT: 29# (EMPTY)
31# (WITH CARBON)



MeadWestvaco

DR. NAME		SERIES 90HM	
DATE		CABINET VAPOR ADSORBER	
REV. 02/09/20		DRAWING NUMBER	
SCALE 1"=1'-0"		90HM	REV.